



**henderson library /unitec facilities**

11/07/03


Prepared for WAITAKERE CITY COUNCIL

Drawing SCHEME B LEVEL 1 STREET

Scale 1:500

Job no 312

Drawing no B-A1-04 Issue —

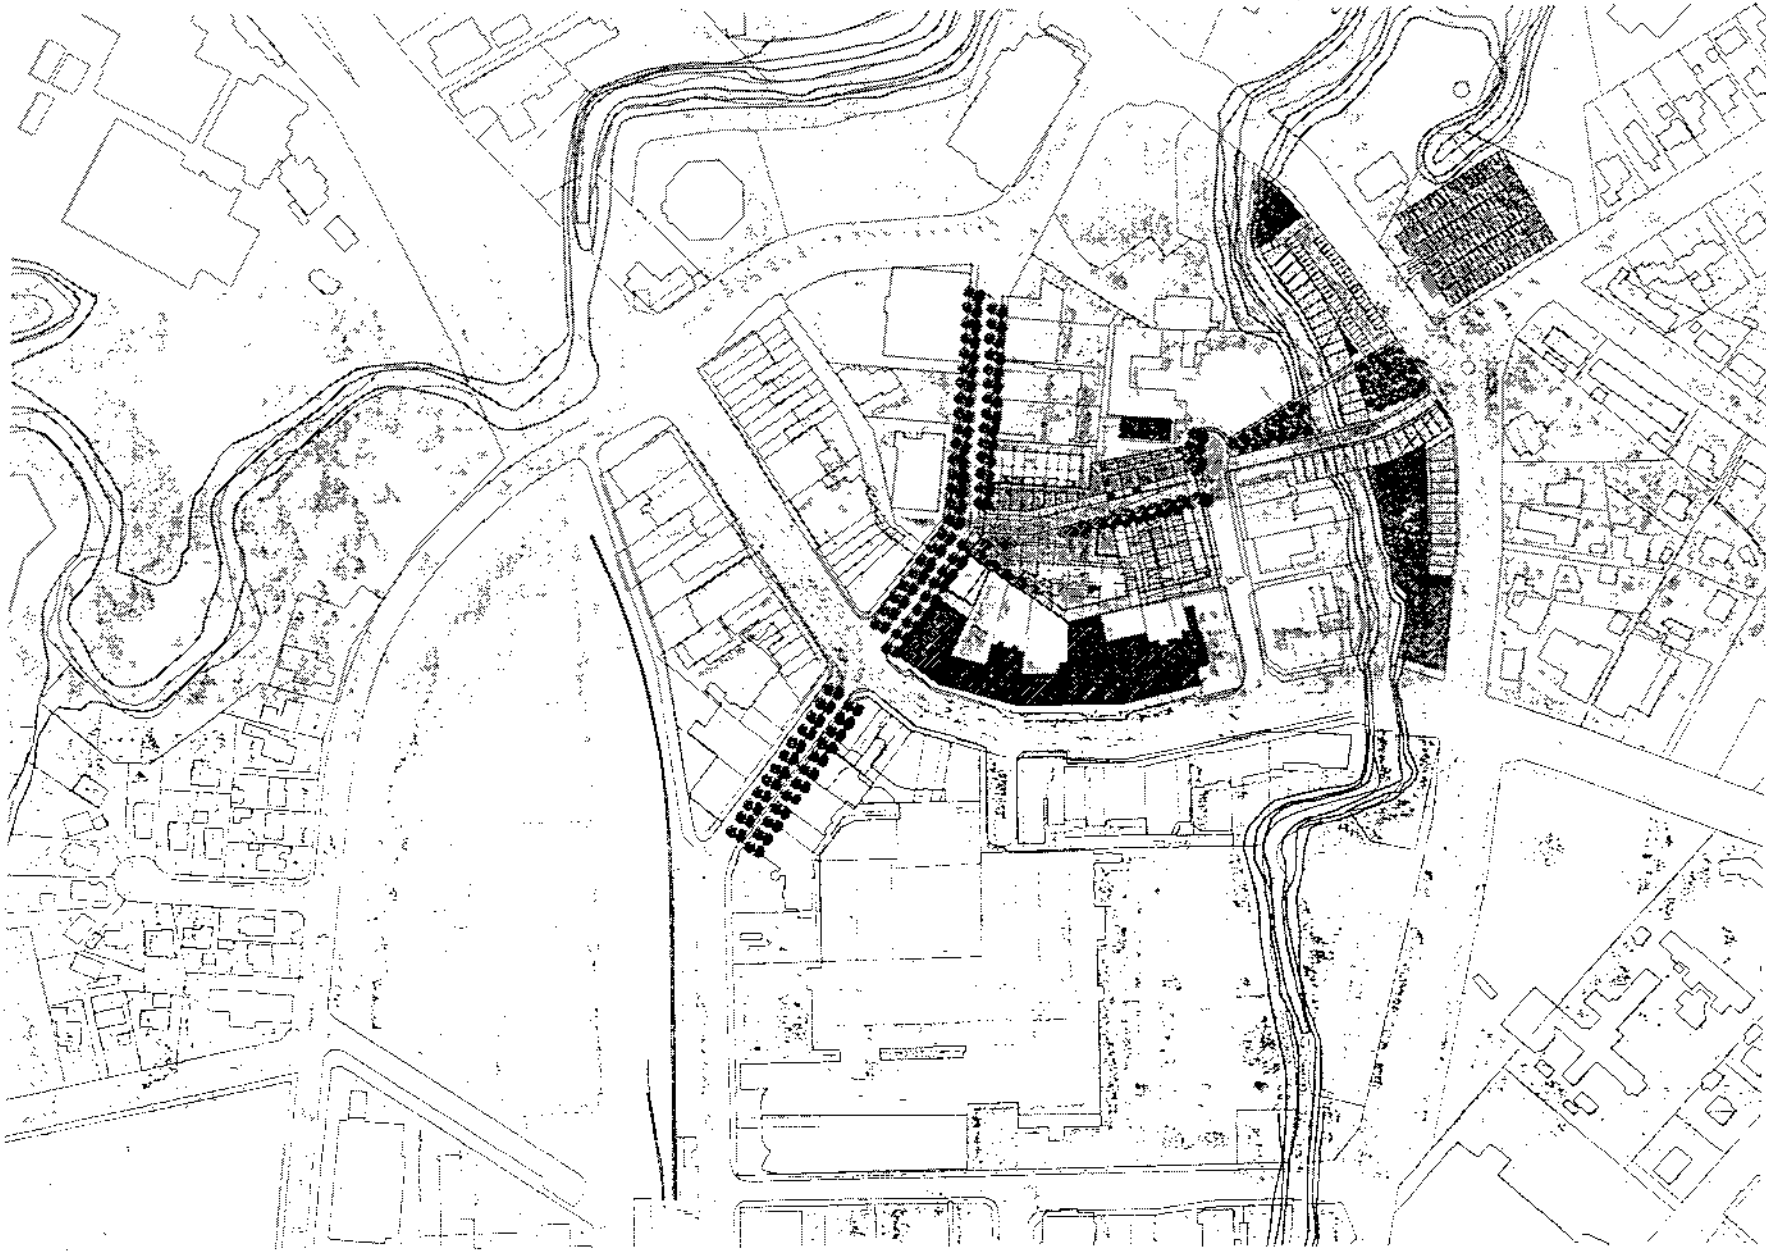

A93



**henderson library /unitec facilities**

11/07/03

Prepared for WAITAKERE CITY COUNCIL

Drawing SCHEME B- SITE PLAN

Scale 1:2500

Job no 312

Drawing no

Issue